

ANA STUDIO ARCHITECTURE, PC
 ANA RESKREIS, RA
 280 RIVERSIDE DRIVE (8th), NEW YORK, N.Y. 10025
 +1516.641.5416 +33 (0) 43 86 24 55
 ANASTUDIO@GMAIL.COM
 WWW.FRENCHDRIVE.COM

WEXLER RESIDENCE
 300 SOUTHPOINTE DR.
 4304
 MIAMI BEACH, FL.
 33139


NOTES

No.	Date	Description

TITLE
 EXISTING PLUMBING FLOOR PLAN


SEAL & SIGNATURE	DATE: 12/12/2023
DRAWN BY:	CHECKED BY:
DWG. No:	

Fine Line Engineers Inc.
 Electrical, Mechanical, Plumbing
 Fire Protection, Construction Administration
 2089 W. 76TH STREET Hialeah, FL 33016
 Voice: 786.953-4901 - Fax: 786.953-4907
 E-mail: admin@fineengineers.com
 GEORGE FREJO, P.E.
 REGISTERED ENGINEER NO. 35578
 STATE OF FLORIDA C44-23786

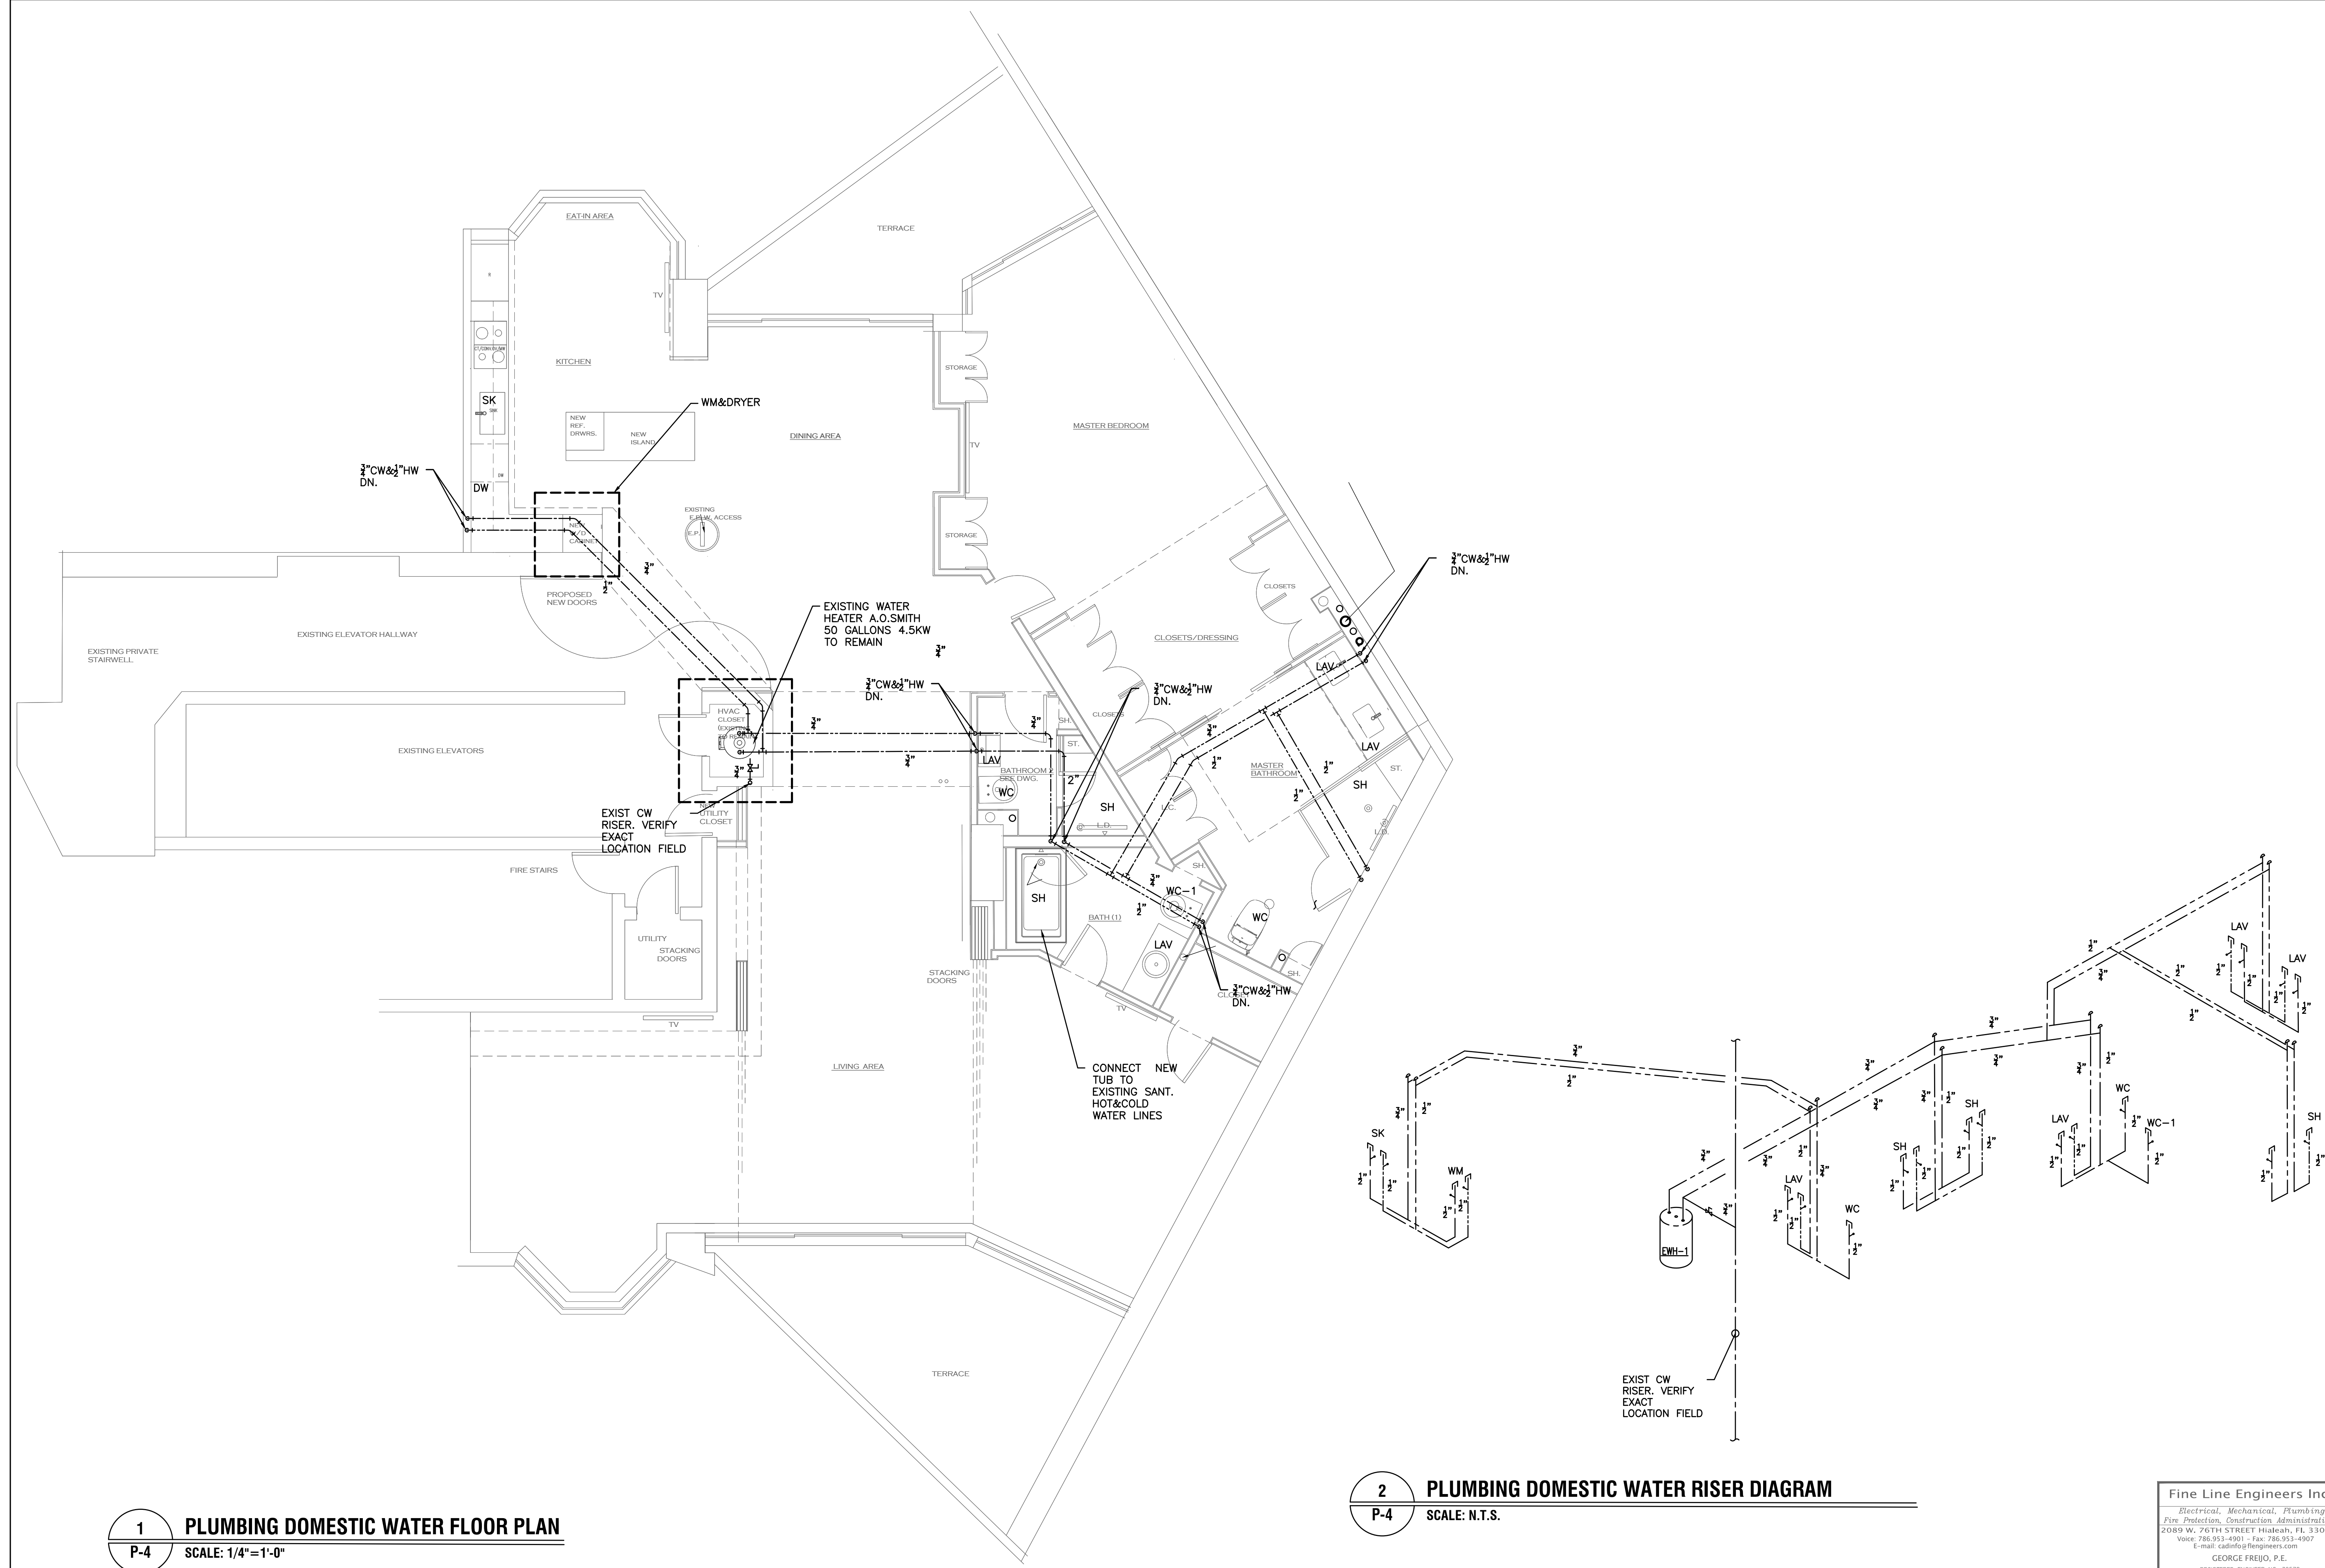

1 PLUMBING DOMESTIC WATER FLOOR PLAN
 SCALE: 1/4"=1'-0"

2 PLUMBING DOMESTIC WATER RISER DIAGRAM
 SCALE: N.T.S.

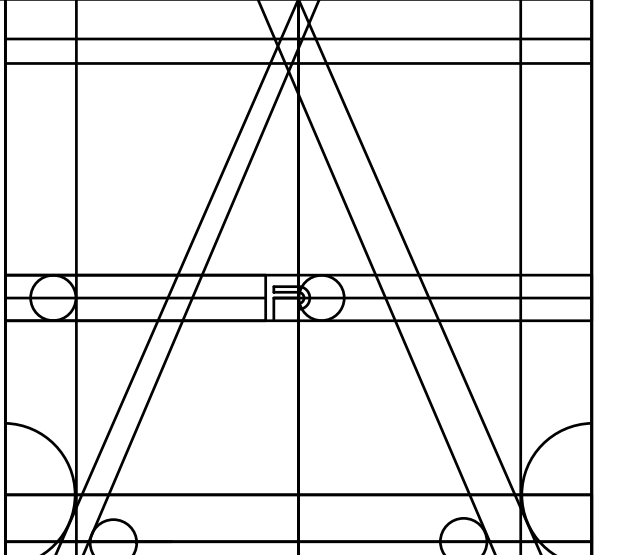

ANA STUDIO ARCHITECTURE, PC
 ANA RESKREIS, RA
 280 RIVERSIDE DRIVE (SU), NEW YORK, N.Y. 10025
 +1 212 644 5816 +1 212 644 86 24 25
 ANASTUDIO2013@GMAIL.COM
 WWW.FRENCHIDRIS.COM

WEXLER RESIDENCE
 300 SOUTHPOINTE DR.
 4304

MIAMI BEACH, FL.
 33139

NOTES

Rev	Date	Description
1	B.D.C.	3/14/24

TITLE
PLUMBING DOMESTIC WATER FLOOR PLAN & RISER DIAGRAM

SCALE SIGNATURE:	DATE: 12/12/2023
	PROJECT NO.:
	DRAWN BY:
	CHECKED BY:
	DRWG. NO.:

P-4

Fine Line Engineers Inc.
 Electrical, Mechanical, Plumbing
 Fire Protection, Construction Administration
 2089 W. 76TH STREET Hialeah, FL 33016
 Voice: 786.953-4901 Fax: 786.953-4907
 E-mail: cad@fineengineers.com
 GEORGE FREJO, P.E.
 REGISTERED ENGINEER NO. 32276
 STATE OF FLORIDA CAP. 29786